


ISSUED FOR:	CD	NO	REVISION	DATE
ISSUE DATE:	8/5/2019			8/05/2019
SCALE:	AS SHOWN		REBID REVISION	
DESIGNED BY:	LCH / GMS			
DRAWN BY:	GMS			
CHECKED BY:	LCH			

LAKELAND TRANSFER CENTER
LAKELAND COMMUNITY COLLEGE
 7601 CLOCKTOWER DR., KIRTLAND, OH 44094

PROJECT NO.	18050002
DISCIPLINE	CIVIL
SHEET NAME	C_02
SHEET	7
OF	55

DEMOLITION PLAN

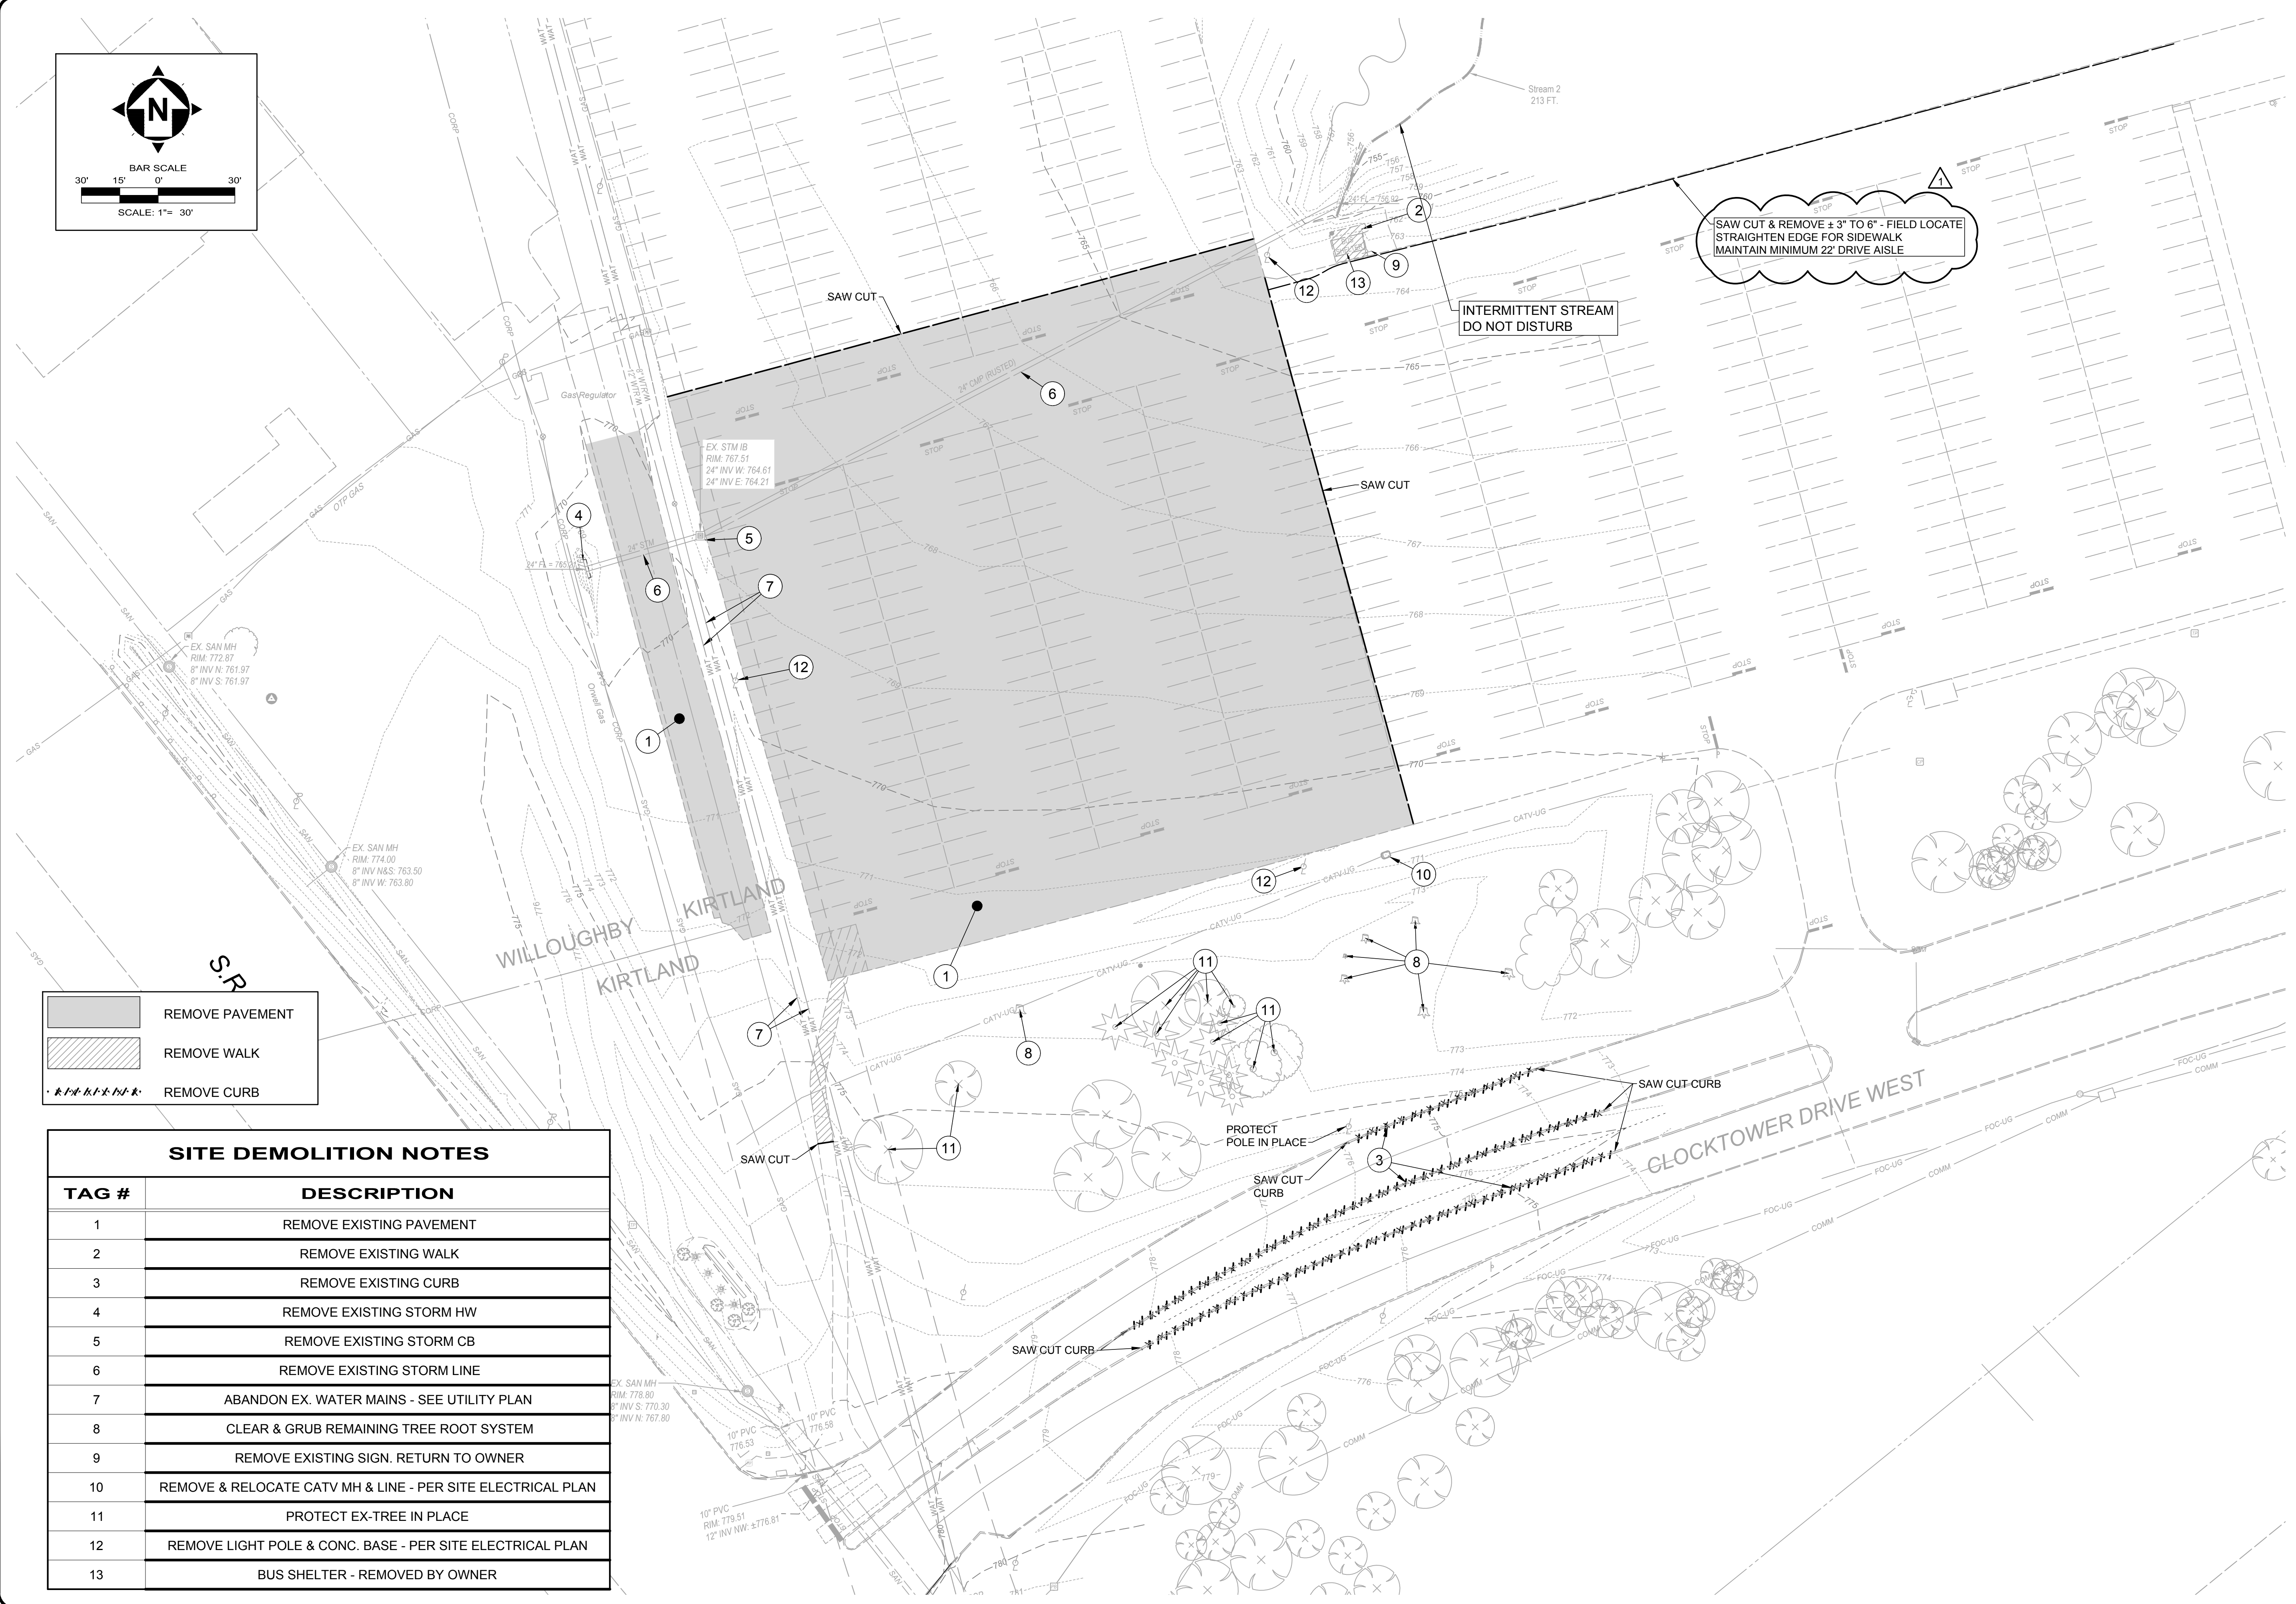

REMOVE PAVEMENT (Solid grey fill)

REMOVE WALK (Hatched pattern)

REMOVE CURB (Dashed line pattern)

SITE DEMOLITION NOTES	
TAG #	DESCRIPTION
1	REMOVE EXISTING PAVEMENT
2	REMOVE EXISTING WALK
3	REMOVE EXISTING CURB
4	REMOVE EXISTING STORM HW
5	REMOVE EXISTING STORM CB
6	REMOVE EXISTING STORM LINE
7	ABANDON EX. WATER MAINS - SEE UTILITY PLAN
8	CLEAR & GRUB REMAINING TREE ROOT SYSTEM
9	REMOVE EXISTING SIGN. RETURN TO OWNER
10	REMOVE & RELOCATE CATV MH & LINE - PER SITE ELECTRICAL PLAN
11	PROTECT EX-TREE IN PLACE
12	REMOVE LIGHT POLE & CONC. BASE - PER SITE ELECTRICAL PLAN
13	BUS SHELTER - REMOVED BY OWNER

H:\2018\18050002\DWG\SHEET\C_02_02_850219 1:25 PM - GEORGE STEVENS