
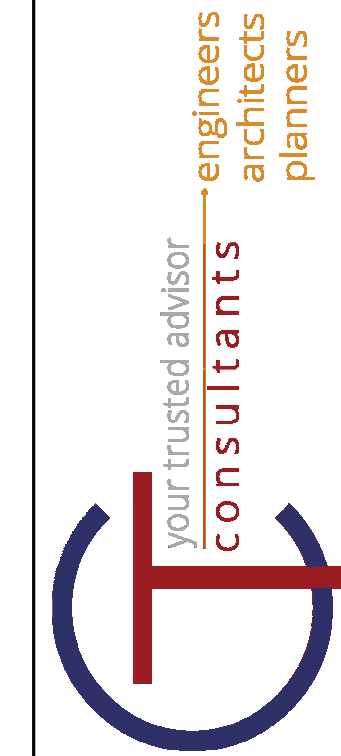


FIRE DEPARTMENT VEHICLE EXHAUST CAPTURE PROJECT CITY OF SPRINGDALE

12147 LAWNVIEW AVE. SPRINGDALE, OHIO 45246

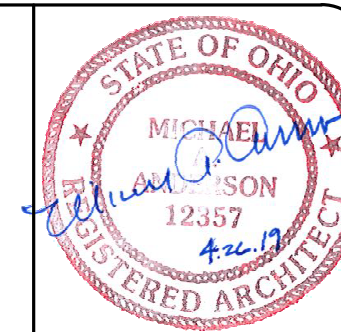

PROJECT DIRECTORY

**ARCHITECTURE,
STRUCTURAL, AND
CIVIL ENGINEERING**




11120 KENWOOD ROAD
CINCINNATI, OH 45242
(513) 791-1700

**MECHANICAL, ELECTRICAL,
PLUMBING, FIRE PROTECTION, AND
COMMUNICATION TECHNOLOGY
ENGINEERING**



1538 ALEXANDRIA PIKE
FT. THOMAS, KY 41075
(P) 859.442.8050

VICINITY MAP

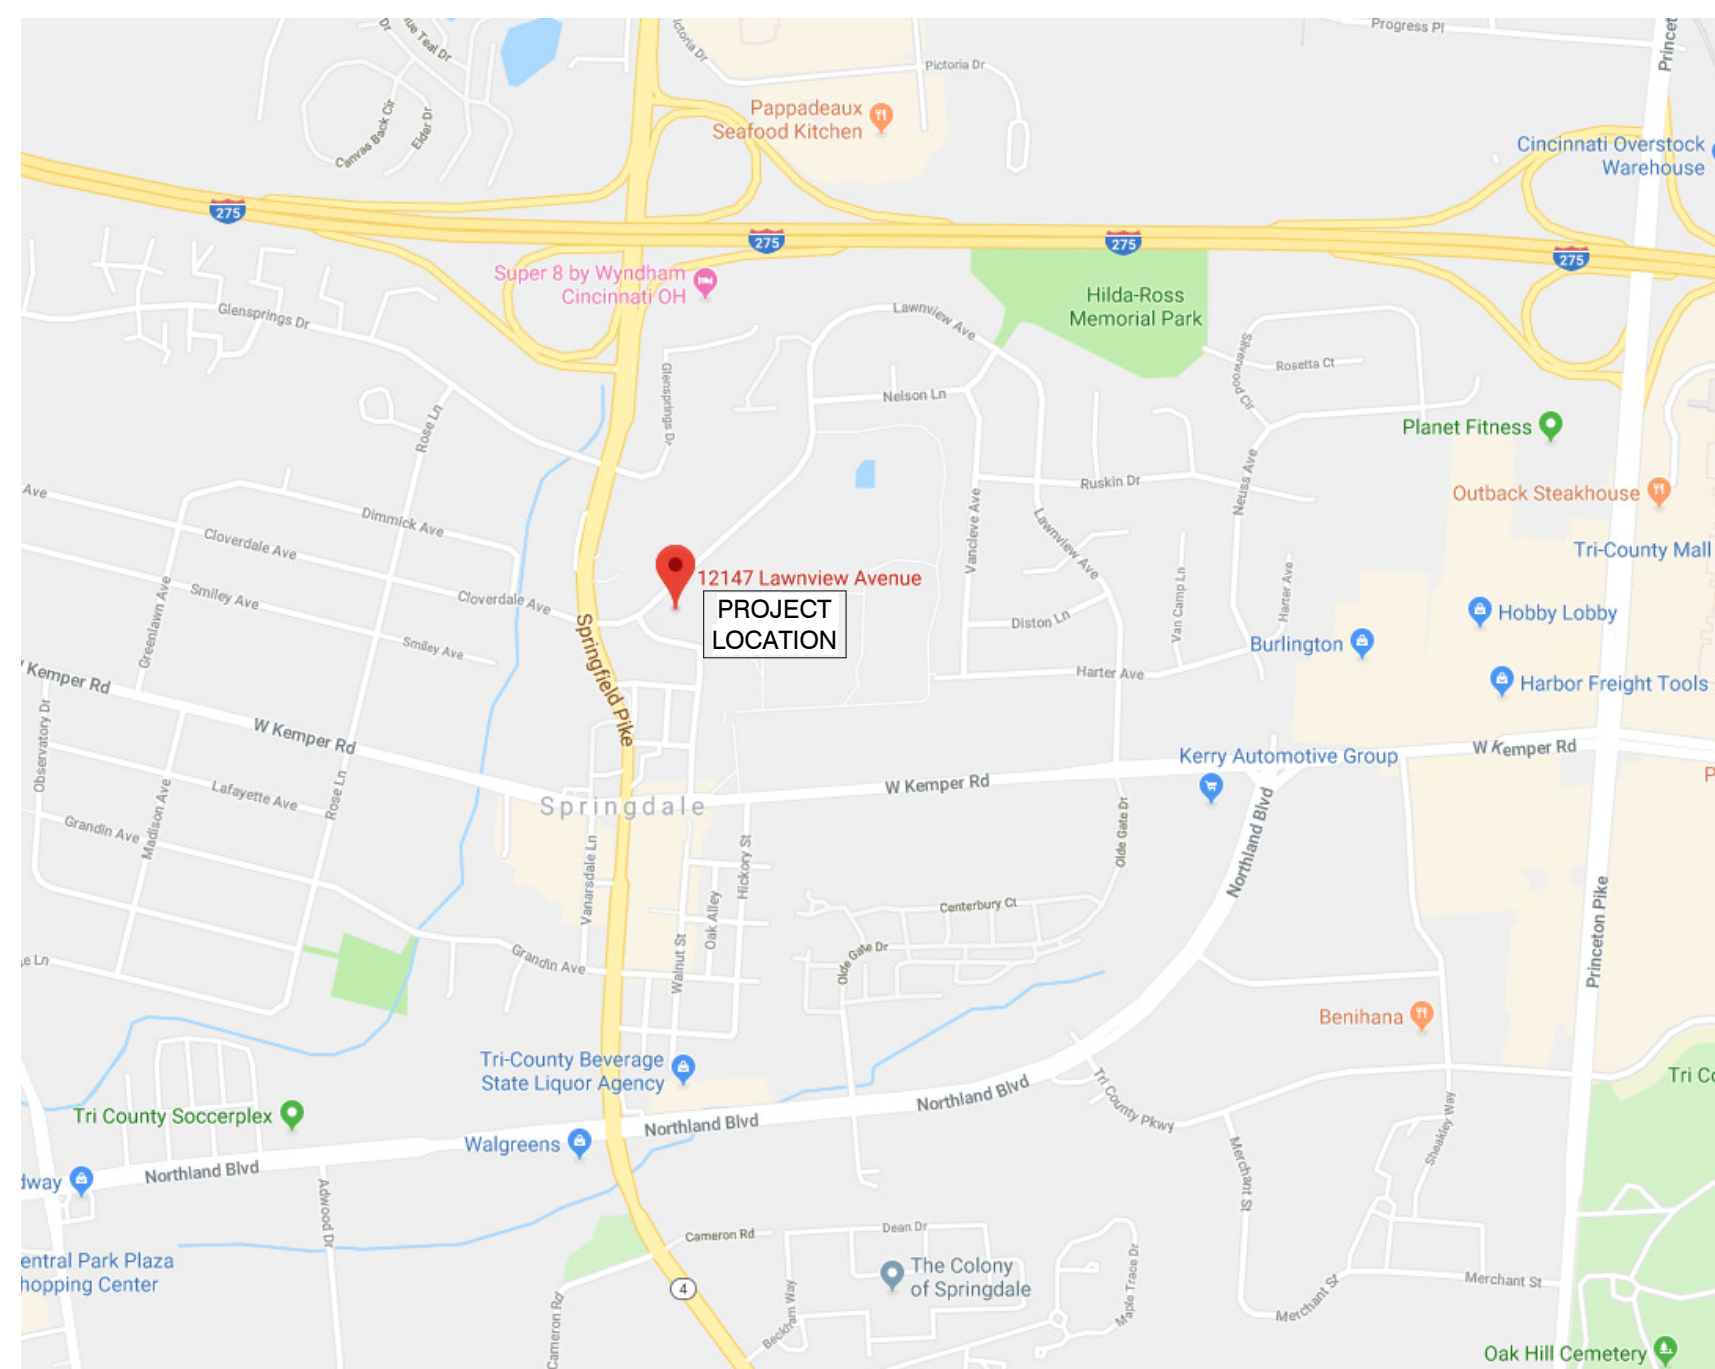

DRAWING INDEX

DWG #	SHEET TITLE	REV	DATE	BY	DESCRIPTION
G001	COVER SHEET	0	05/08/2019	MAND	ISSUED FOR BID
MEP	MECHANICAL, ELECTRICAL, AND PLUMBING				
M-100	MECHANICAL DUCTWORK LEVEL 1 PLAN				
EP100	ELECTRICAL POWER PLAN				
EP601	ELECTRIC POWER - SCHEDULES AND SINGLE LINE DIAGRAM				

NEW OR REVISED ISSUE I = O
NON REVISED ISSUE I = O

DATE	BY	MAND
05/08/2019		

REV	ISSUED FOR BID	REVISIONS
0		

DATE	05/2019
DRAWN BY:	
CHECKED BY:	MAND
APPROVED BY:	MAND
NO.	
PG.	

FIRE DEPARTMENT VEHICLE EXHAUST
CAPTURE PROJECT
CITY OF SPRINGDALE
12147 LAWNVIEW AVE. SPRINGDALE, OHIO 45246
COVER SHEET

SCALE:	
HORZ:	
VERT:	
CONTRACT NO:	190145
SHEET	G001