
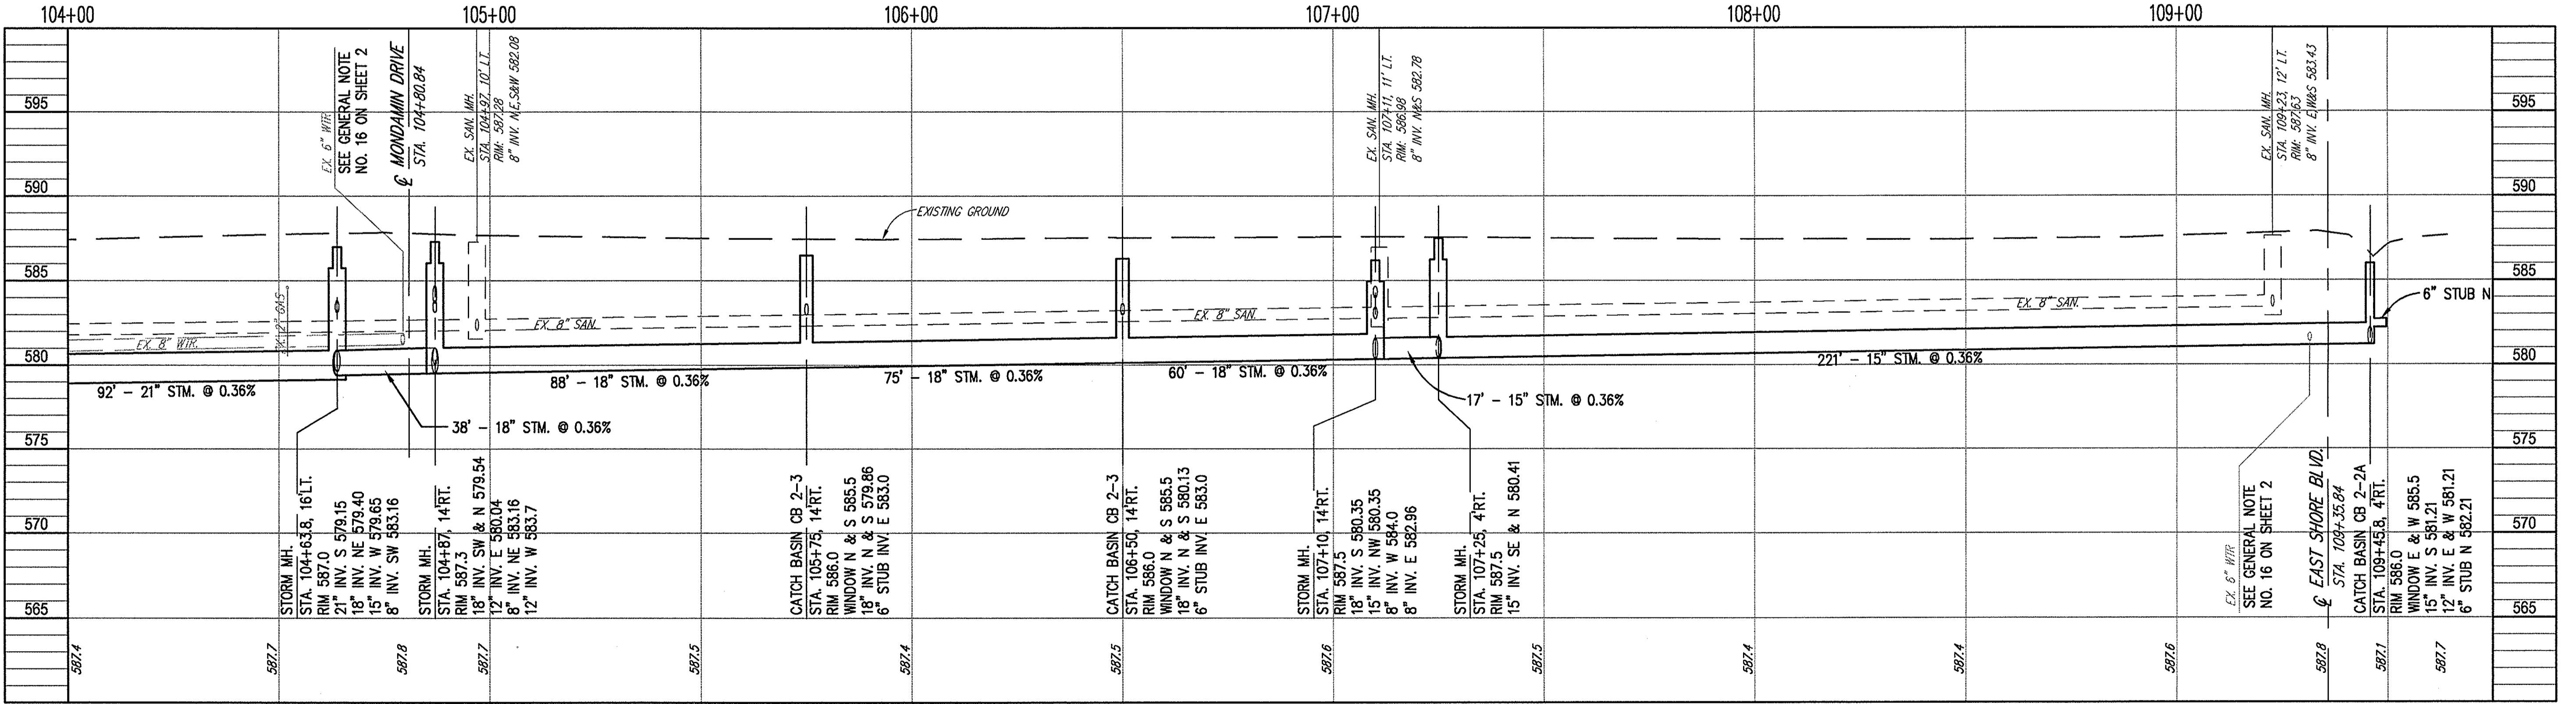
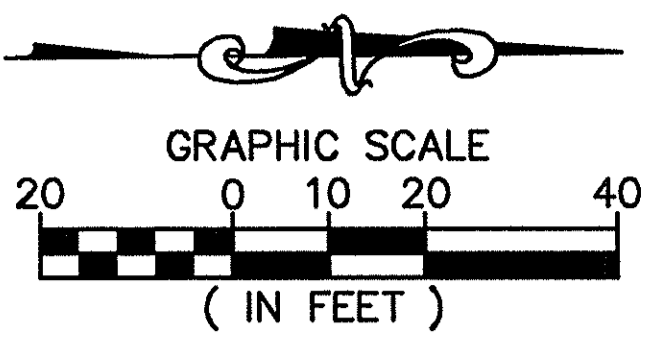


Copyright - Jul 08, 2010 - 4:14pm CT Consultants, Inc.
 Drawing name: H:\2010\10088\dwg\10088PP-TI.dwg Layout: 5 by: schneid

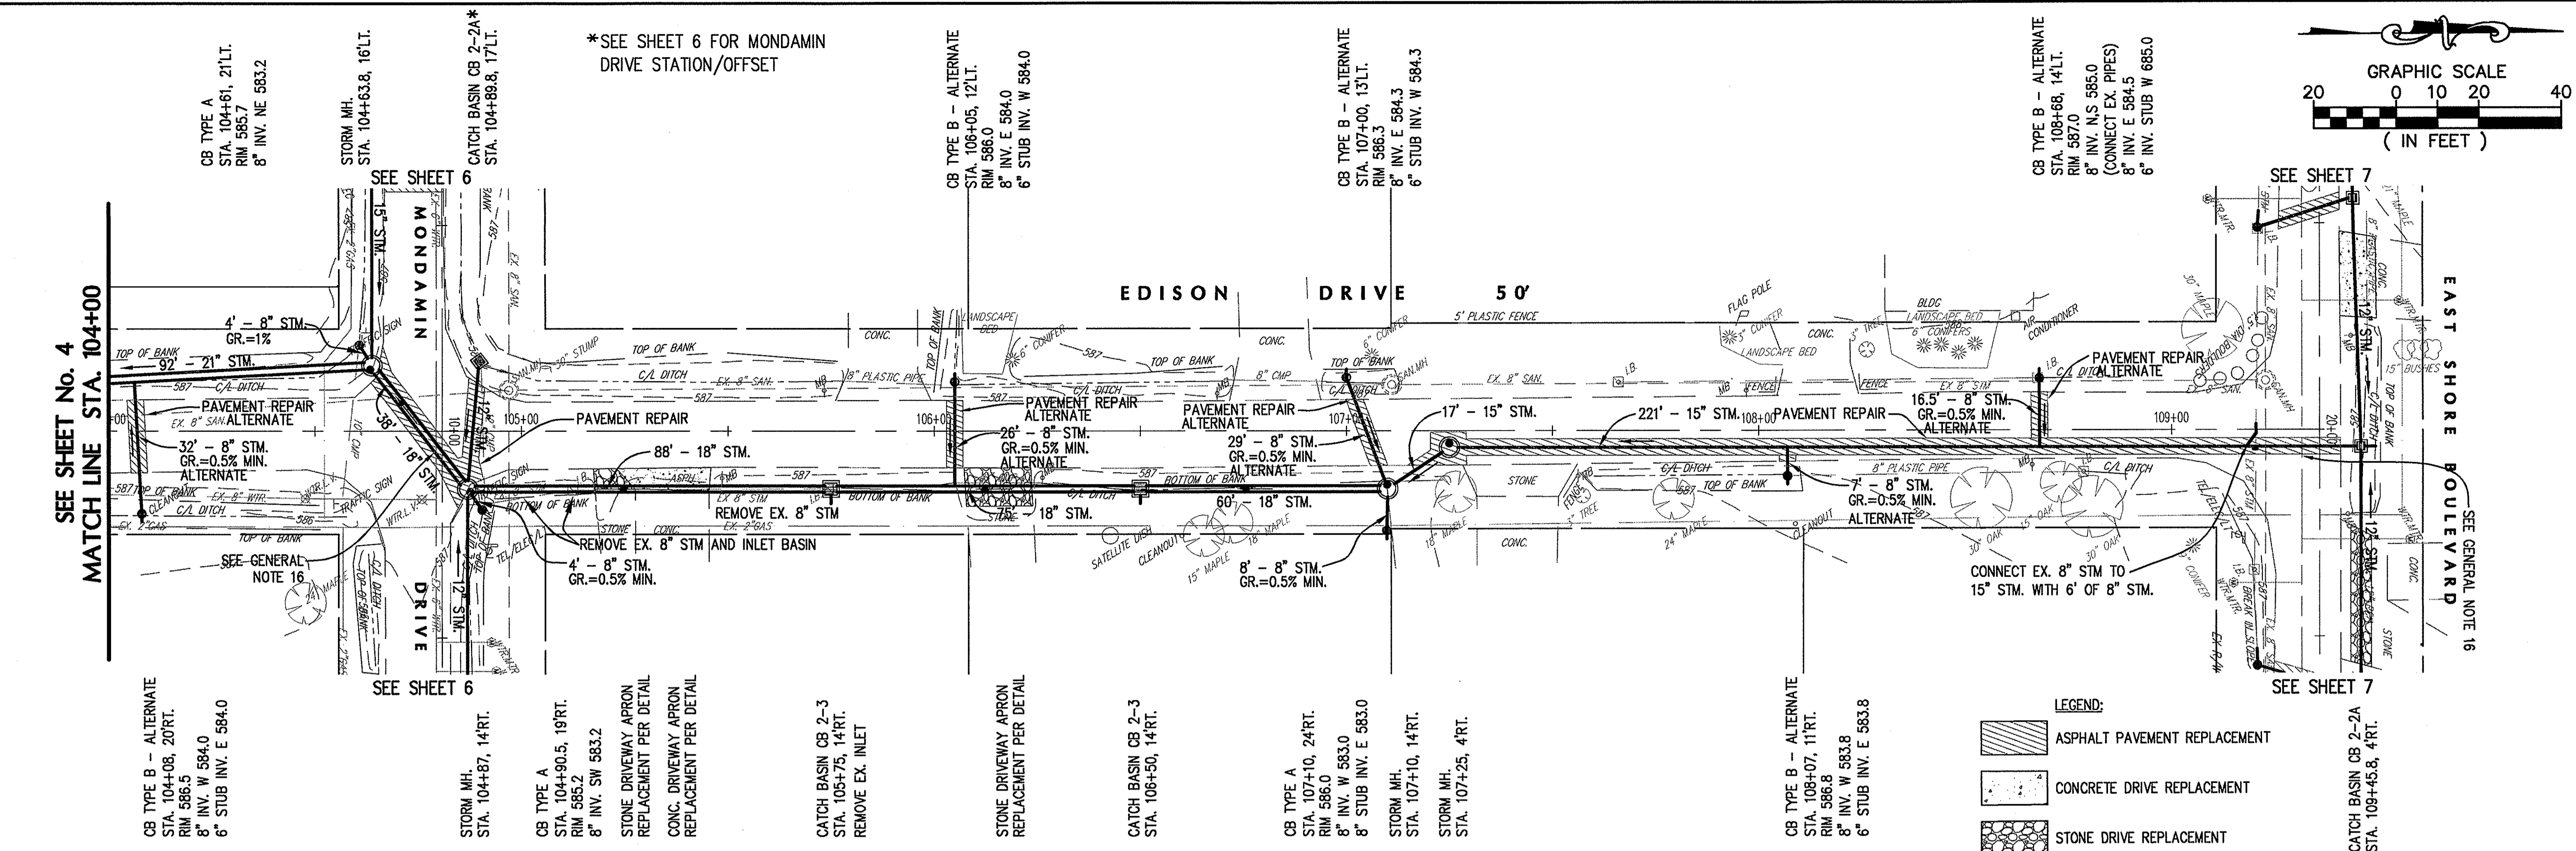

CT Consultants
 engineers | architects | planners
 8150 Sterling Court Mentor, Ohio 44060
 440.951.9000 www.ctconsultants.com

REV. NO.	DESCRIPTION	DATE	BY	CHK'D.

EDISON DRIVE & MONDAMIN DRIVE
STORM SEWER IMPROVEMENTS
 CITY OF EASTLAKE, COUNTY OF LAKE, OHIO

DATE: JULY 2010
 DRAWN BY: LML
 CHECKED BY: TRL
 APPROVED BY: TRL
 F.B. No. 1221 Pg. 110-156

PLAN AND PROFILE
EDISON DRIVE
STA. 104+00 TO STA. 109+00

SCALE	
HOR.	AS NOTED
VERT.	
CONTRACT No.	
10088	
SHEET NO.	OF
5	11