



CT Consultants
 engineers | architects | planners
 8150 Sterling Court, Mentor, Ohio 44860
 440.951.9000 www.ctconsultants.com

EDISON DRIVE & MONDAMIN DRIVE

STORM SEWER IMPROVEMENTS



CITY OF EASTLAKE, COUNTY OF LAKE, OHIO

DATE: JULY 2010
 DRAWN BY: LML
 CHECKED BY: TRL
 APPROVED BY: TRL

PLAN AND PROFILE
EDISON DRIVE
STA. 100+00 TO STA. 104+00

F.B. No. 1221 P.C. 110-158

SCALE: AS NOTED
 CONTRACT NO. 10088
 SHEET NO. 4 OF 11

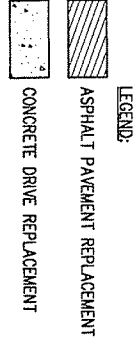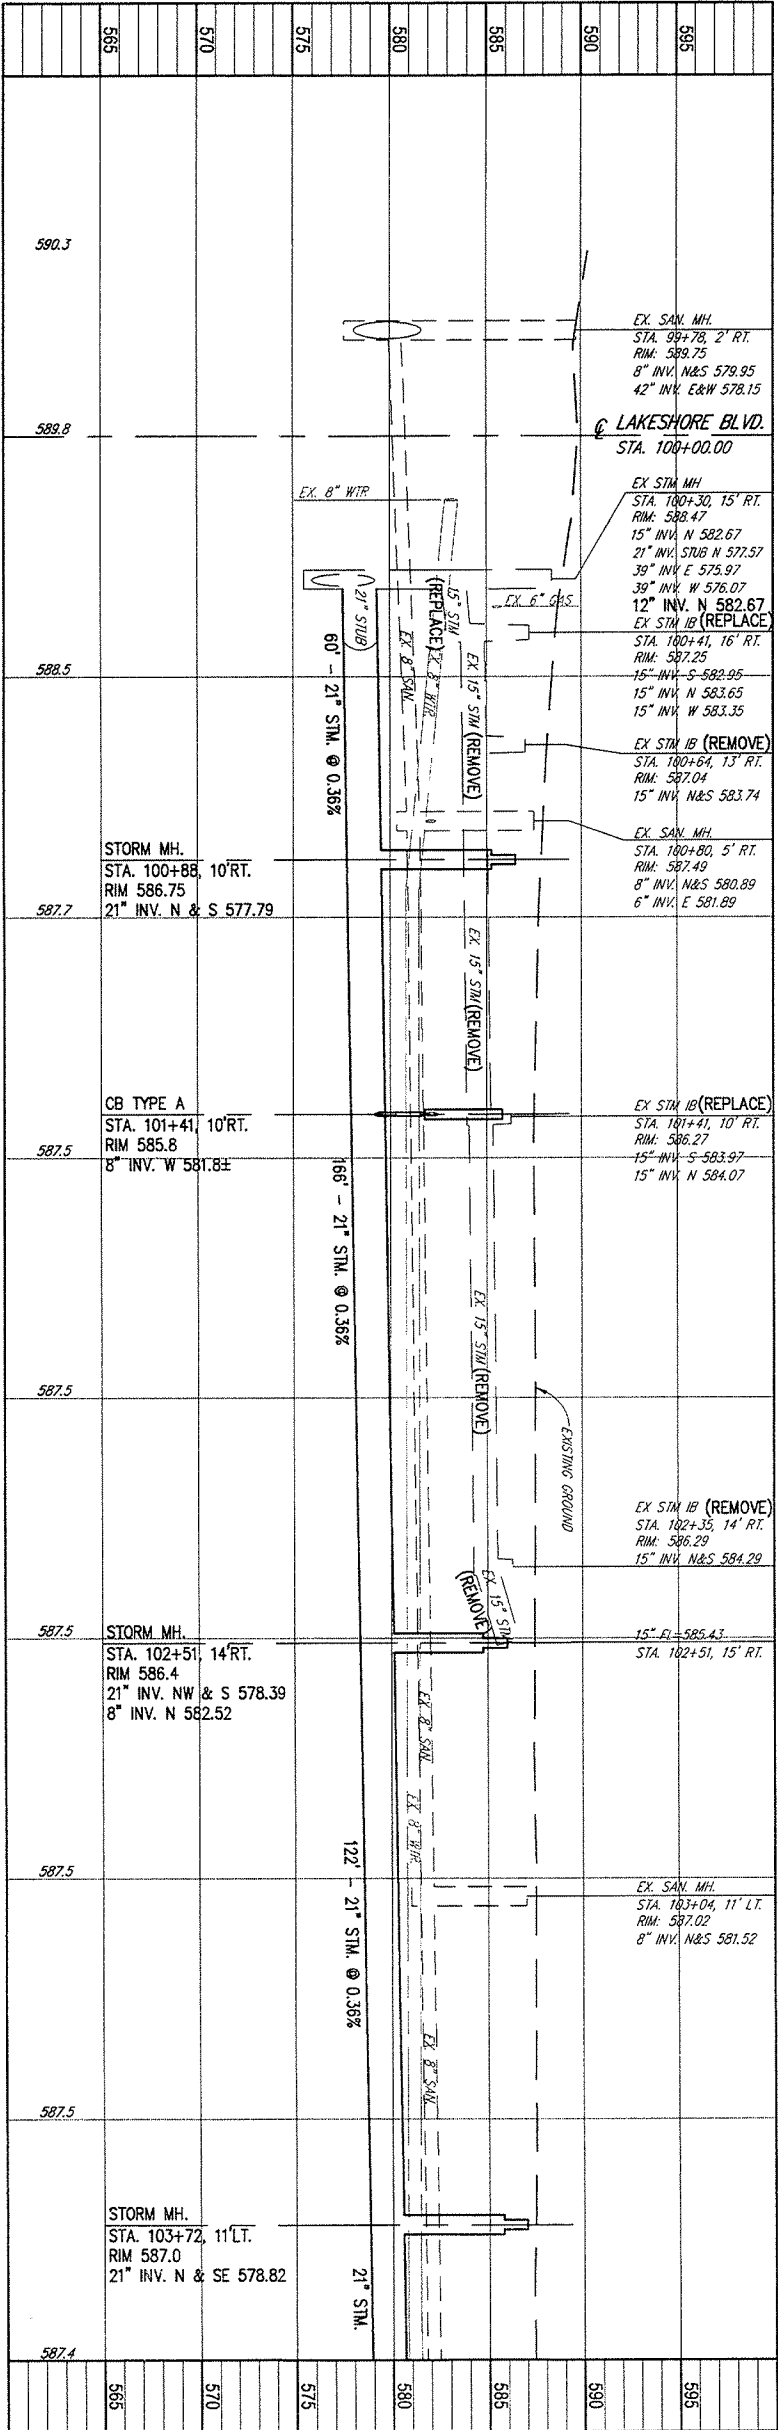

CATCH BASIN CB 2-2B
 STA. 100+41, 16.4' RT.
 RIM 587.2
 12" INV. S 582.95

STORM MH.
 STA. 100+88, 10' RT.
 CONC. DRIVEWAY APRON REPLACEMENT PER DETAIL


CB TYPE A
 STA. 101+41, 10' RT.
 RIM 586.2
 12" INV. E 583.7

CONC. DRIVEWAY APRON REPLACEMENT PER DETAIL

STORM MH.
 STA. 102+51, 14' RT.

CB TYPE A
 STA. 103+02, 20.5' RT.
 RIM 585.5
 8" INV. S 583.0
 (CONNECT EXIST. PIPES)

CONC. DRIVEWAY APRON REPLACEMENT PER DETAIL
 STORM MH.
 STA. 103+72, 11' LT.

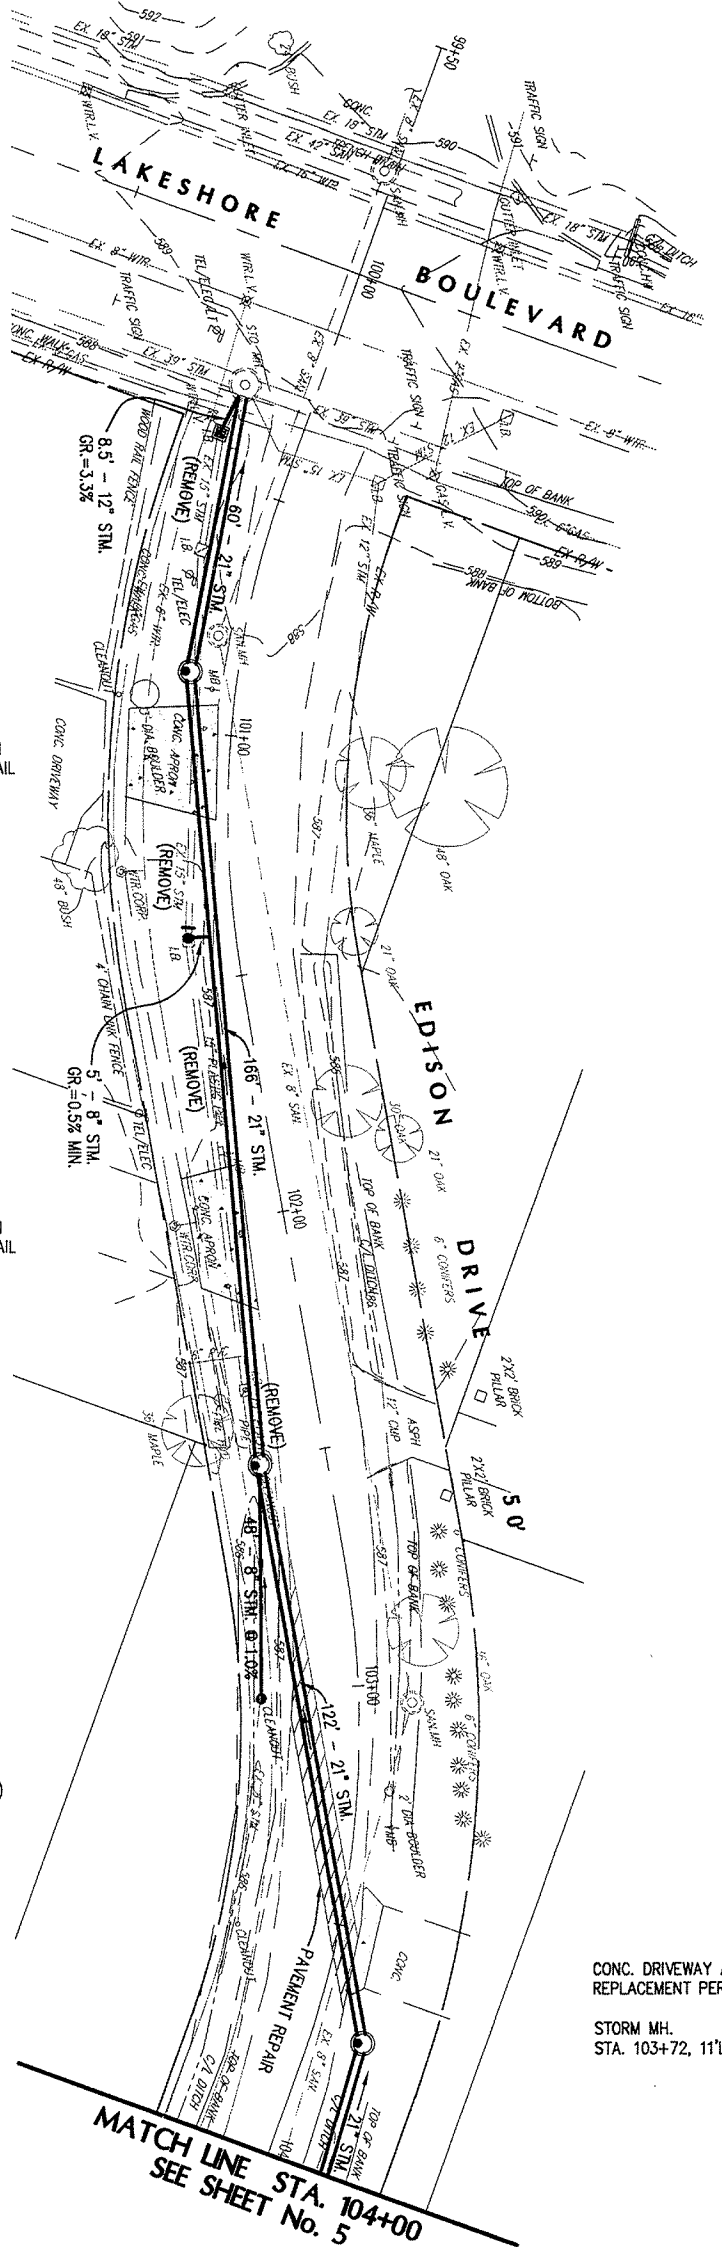

MATCH LINE STA. 104+00
 SEE SHEET No. 5

